



JOHN JOEL DONALDSON, M.D.

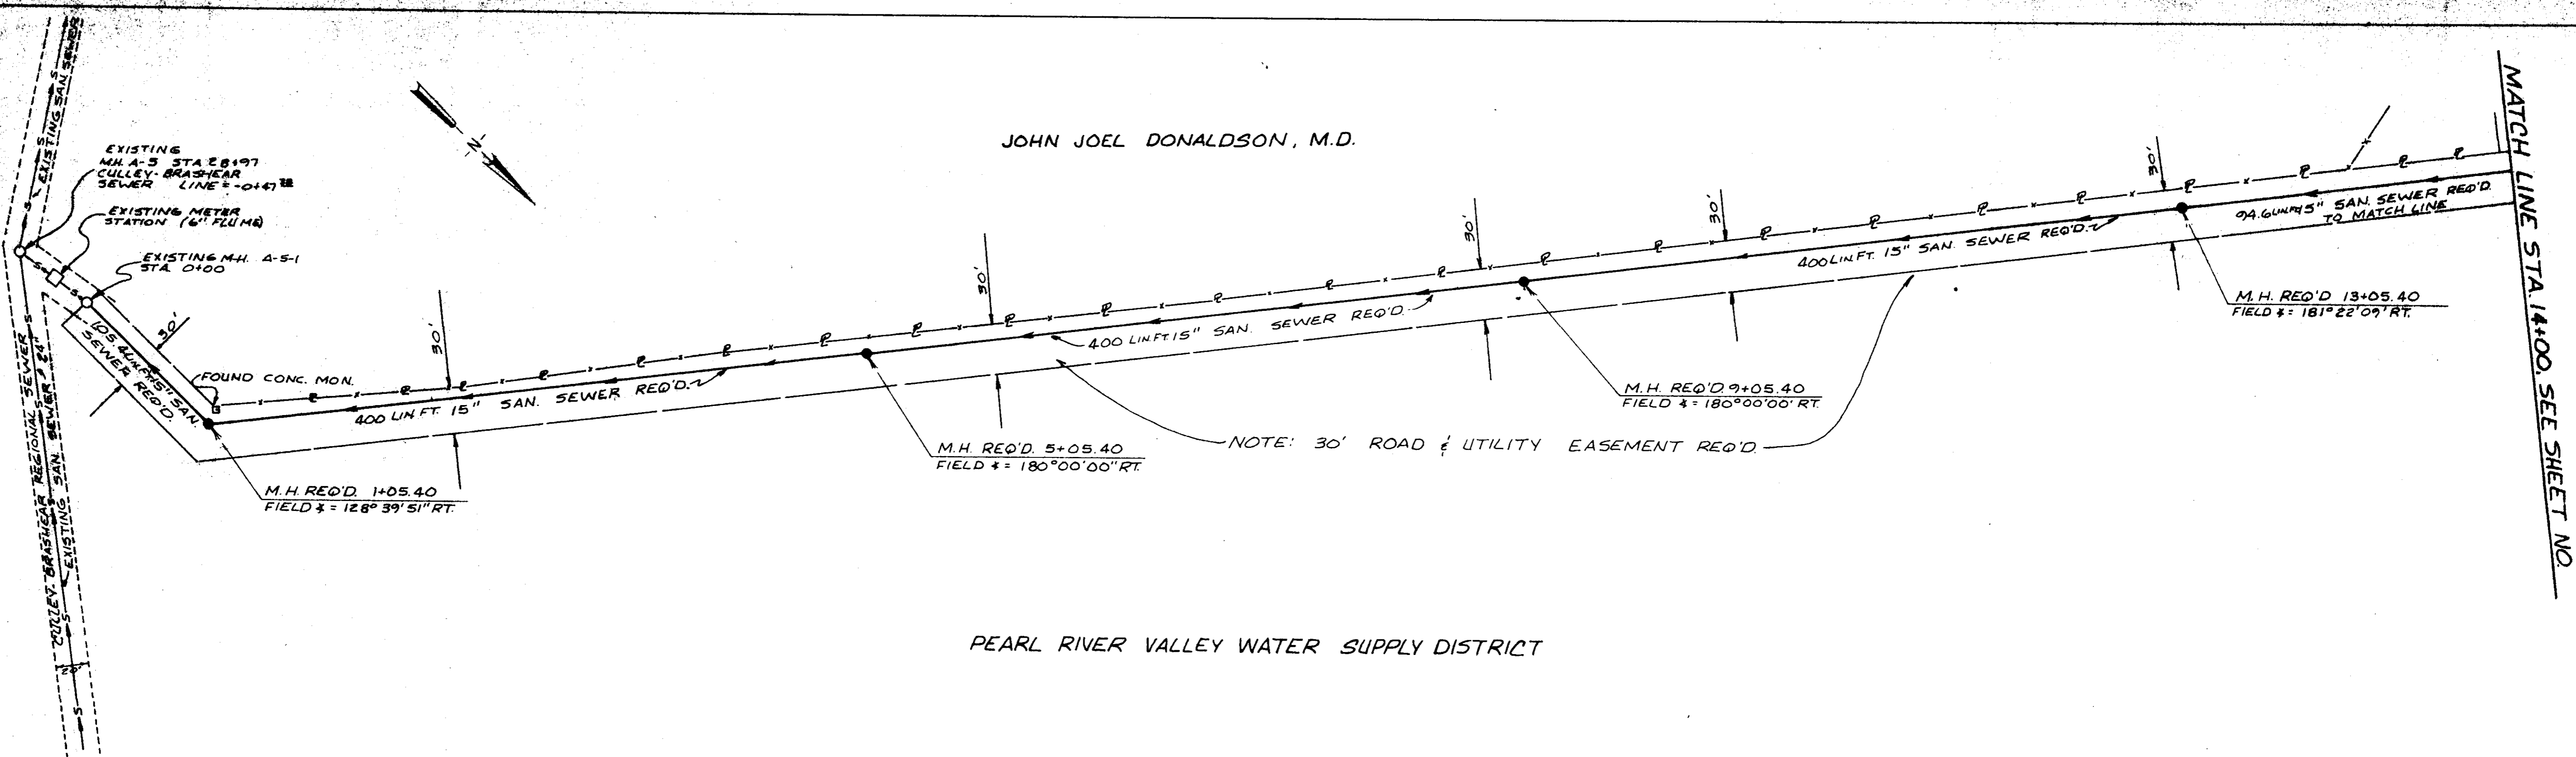

PEARL RIVER VALLEY WATER SUPPLY DISTRICT

SCALE:
1 INCH = 50 FEET - HOR
1 INCH = 5 FEET - VERT

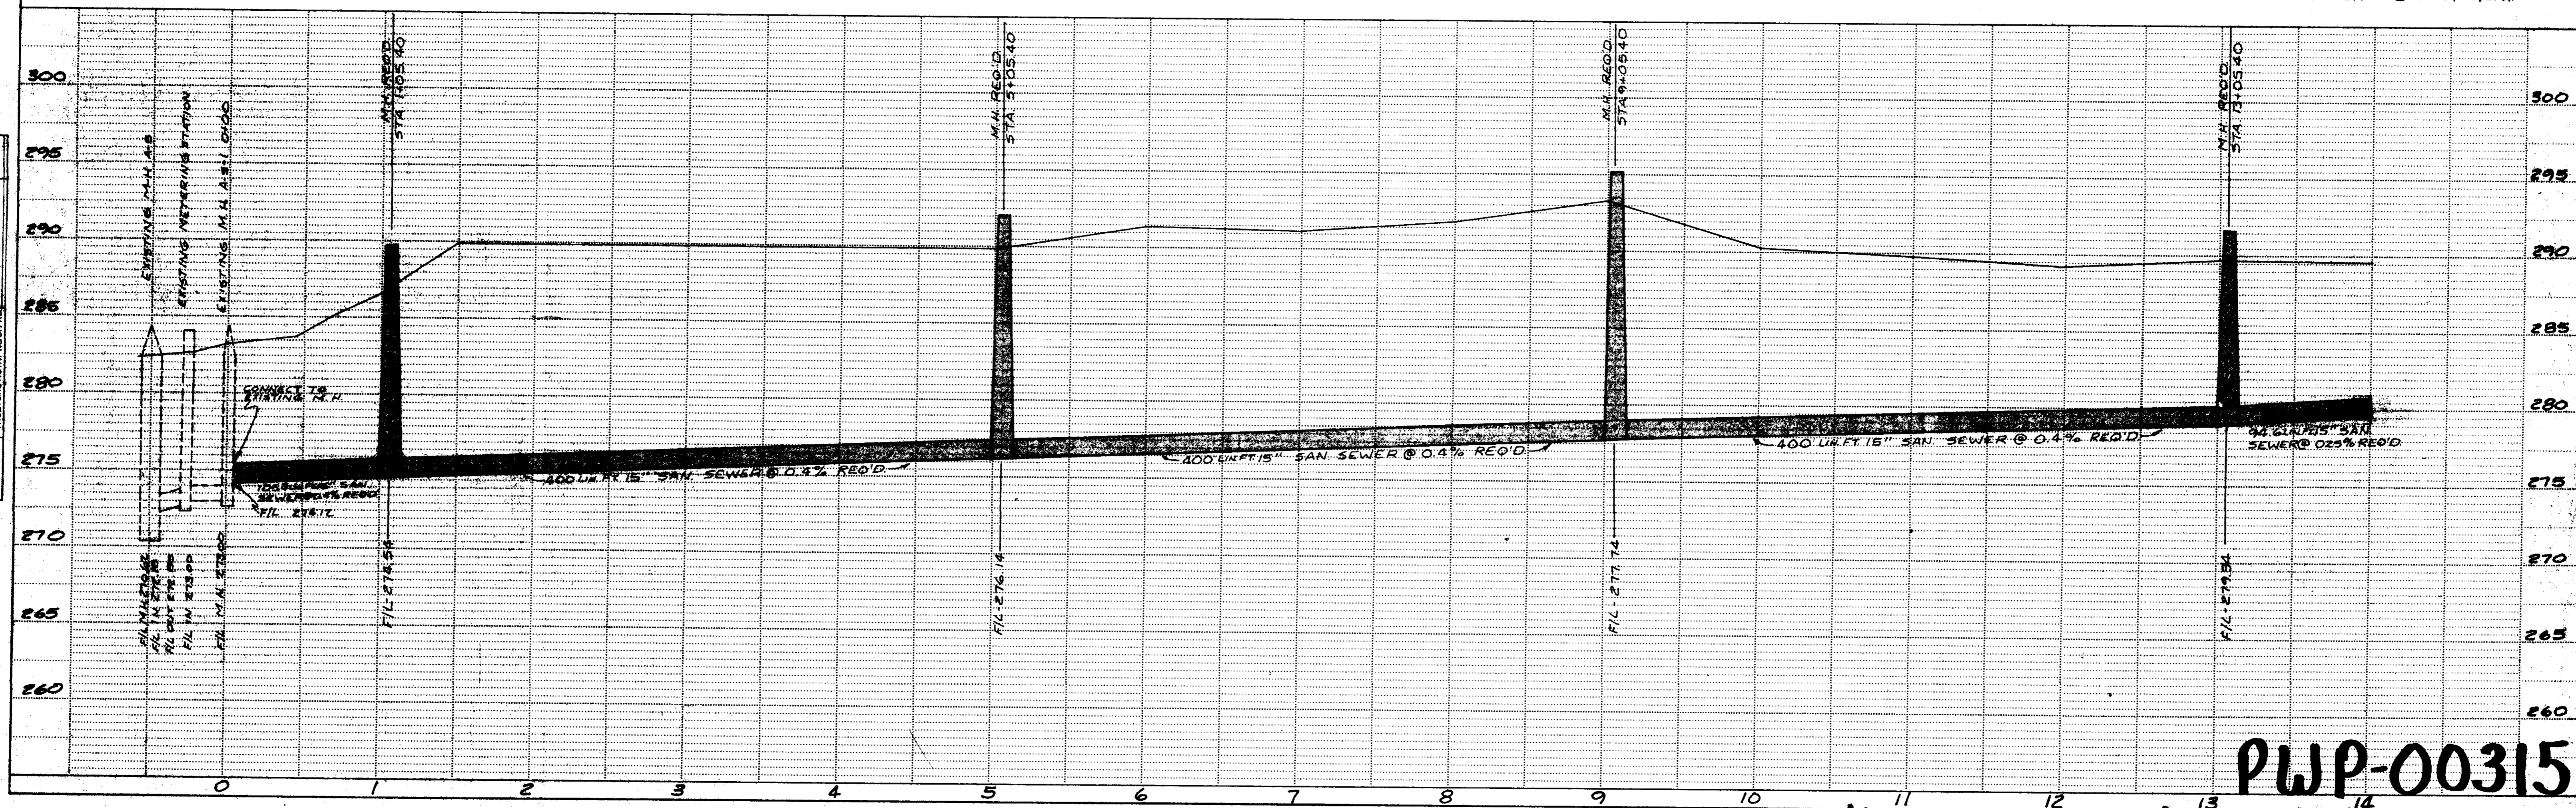

PWP-00315

ROADWAY FEDERAL NO SHEET
PLATE 1-SINGLE PLAN AND PROFILE-FULL DOT
PRINTED IN U.S.A.

Servers Hawthorne Green, Village Hall
Village Square
CULLEY-Brasher Tie on to
Interceptor at Metering Sta. NO 1

WAGGNER ENGINEERING INC.
Civil Engineers - Jackson / Brandon, MS
SHEET NO. 3

